


NO.	DESCRIPTION	DATE	BY	CHECKED
1	Issue for Planning	21/04/22	SC	SC
2	Issue for Building Control	21/04/22	SC	SC
3	Issue for Construction Phase	21/04/22	SC	SC
4	Issue for Completion	21/04/22	SC	SC
5	Issue for Final Handover	21/04/22	SC	SC

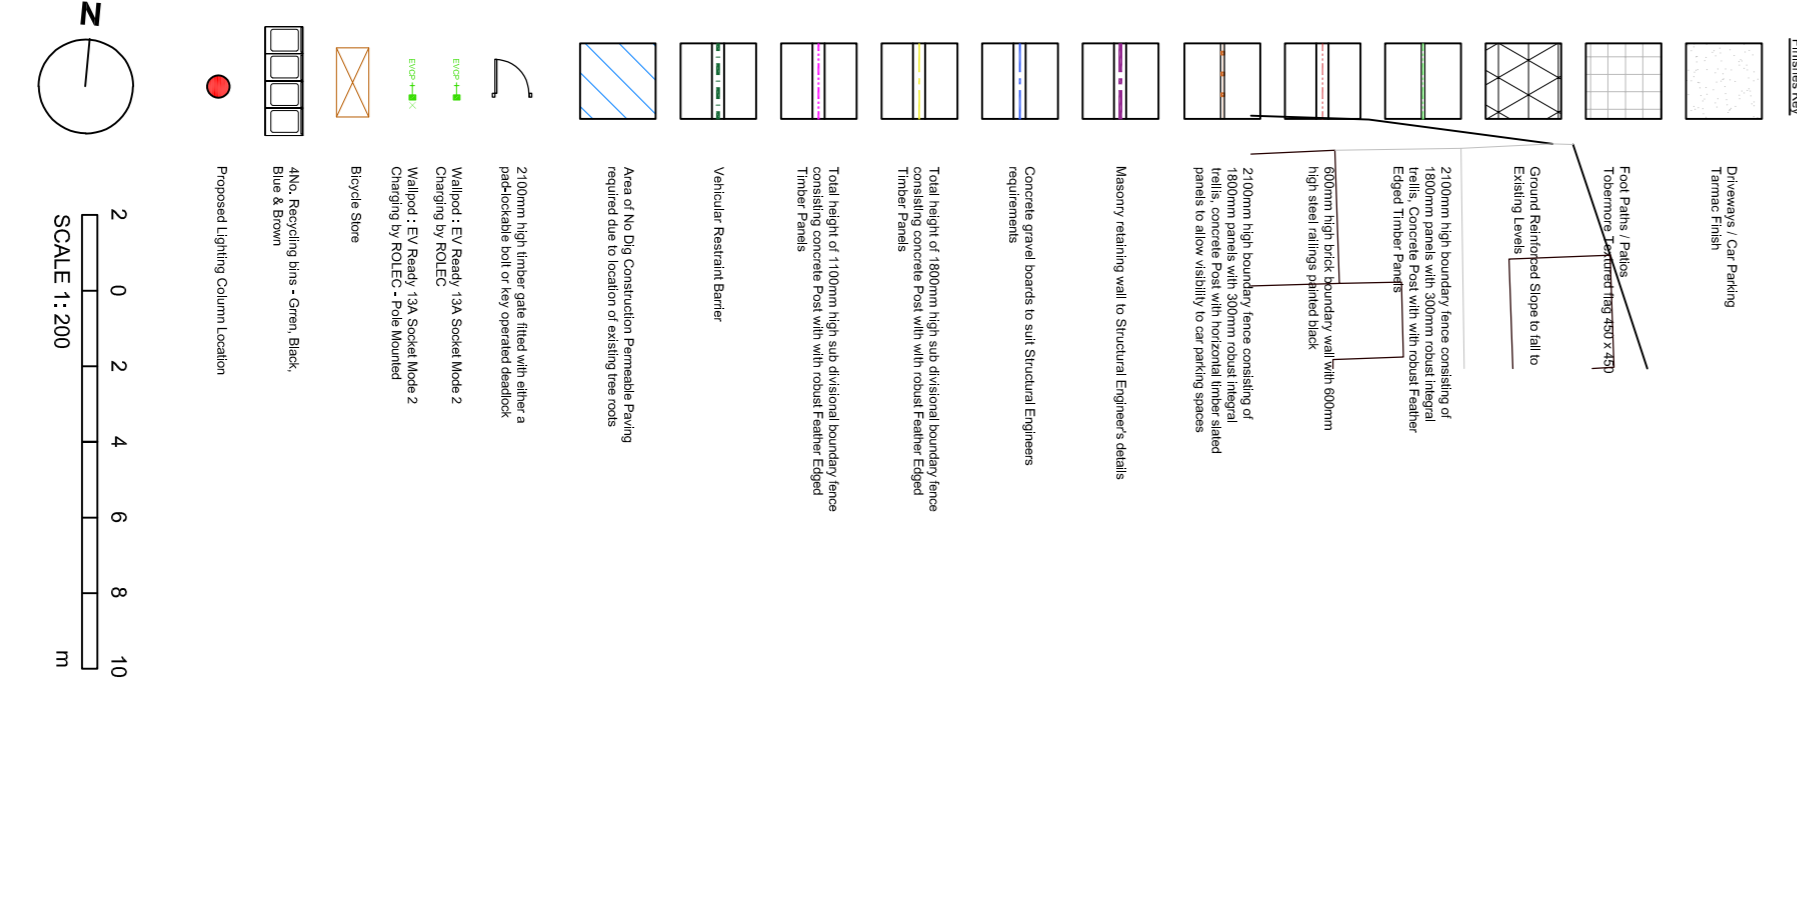

CHESHIRE
 100 High St
 2024 Chester St
 WA1 4DW
 0161 929 7622

SURREY
 Electric Works
 Capenhurst Way
 KT10 9QU
 01372 203 335

SHEFFIELD
 All Work and Social
 212 Building
 143 3AQ
 01451 797 7622

MANCHESTER
 Avenue 10
 13 1BP
 0151 662 0122

LIVERPOOL
 17 Room 10
 L3 1BP
 0151 662 0122

JONATHAN GRANGE, 14 NEW DWELLINGS
 CASSELL & FLETCHER

PROPOSED SITE PLAN
 DWG: 21.04.22 100 C4
 DATE: 28.04.22
 SCALE: 1:200 @ A1
 DRAWN: SC

CALDERPEEL
 ARCHITECTS